


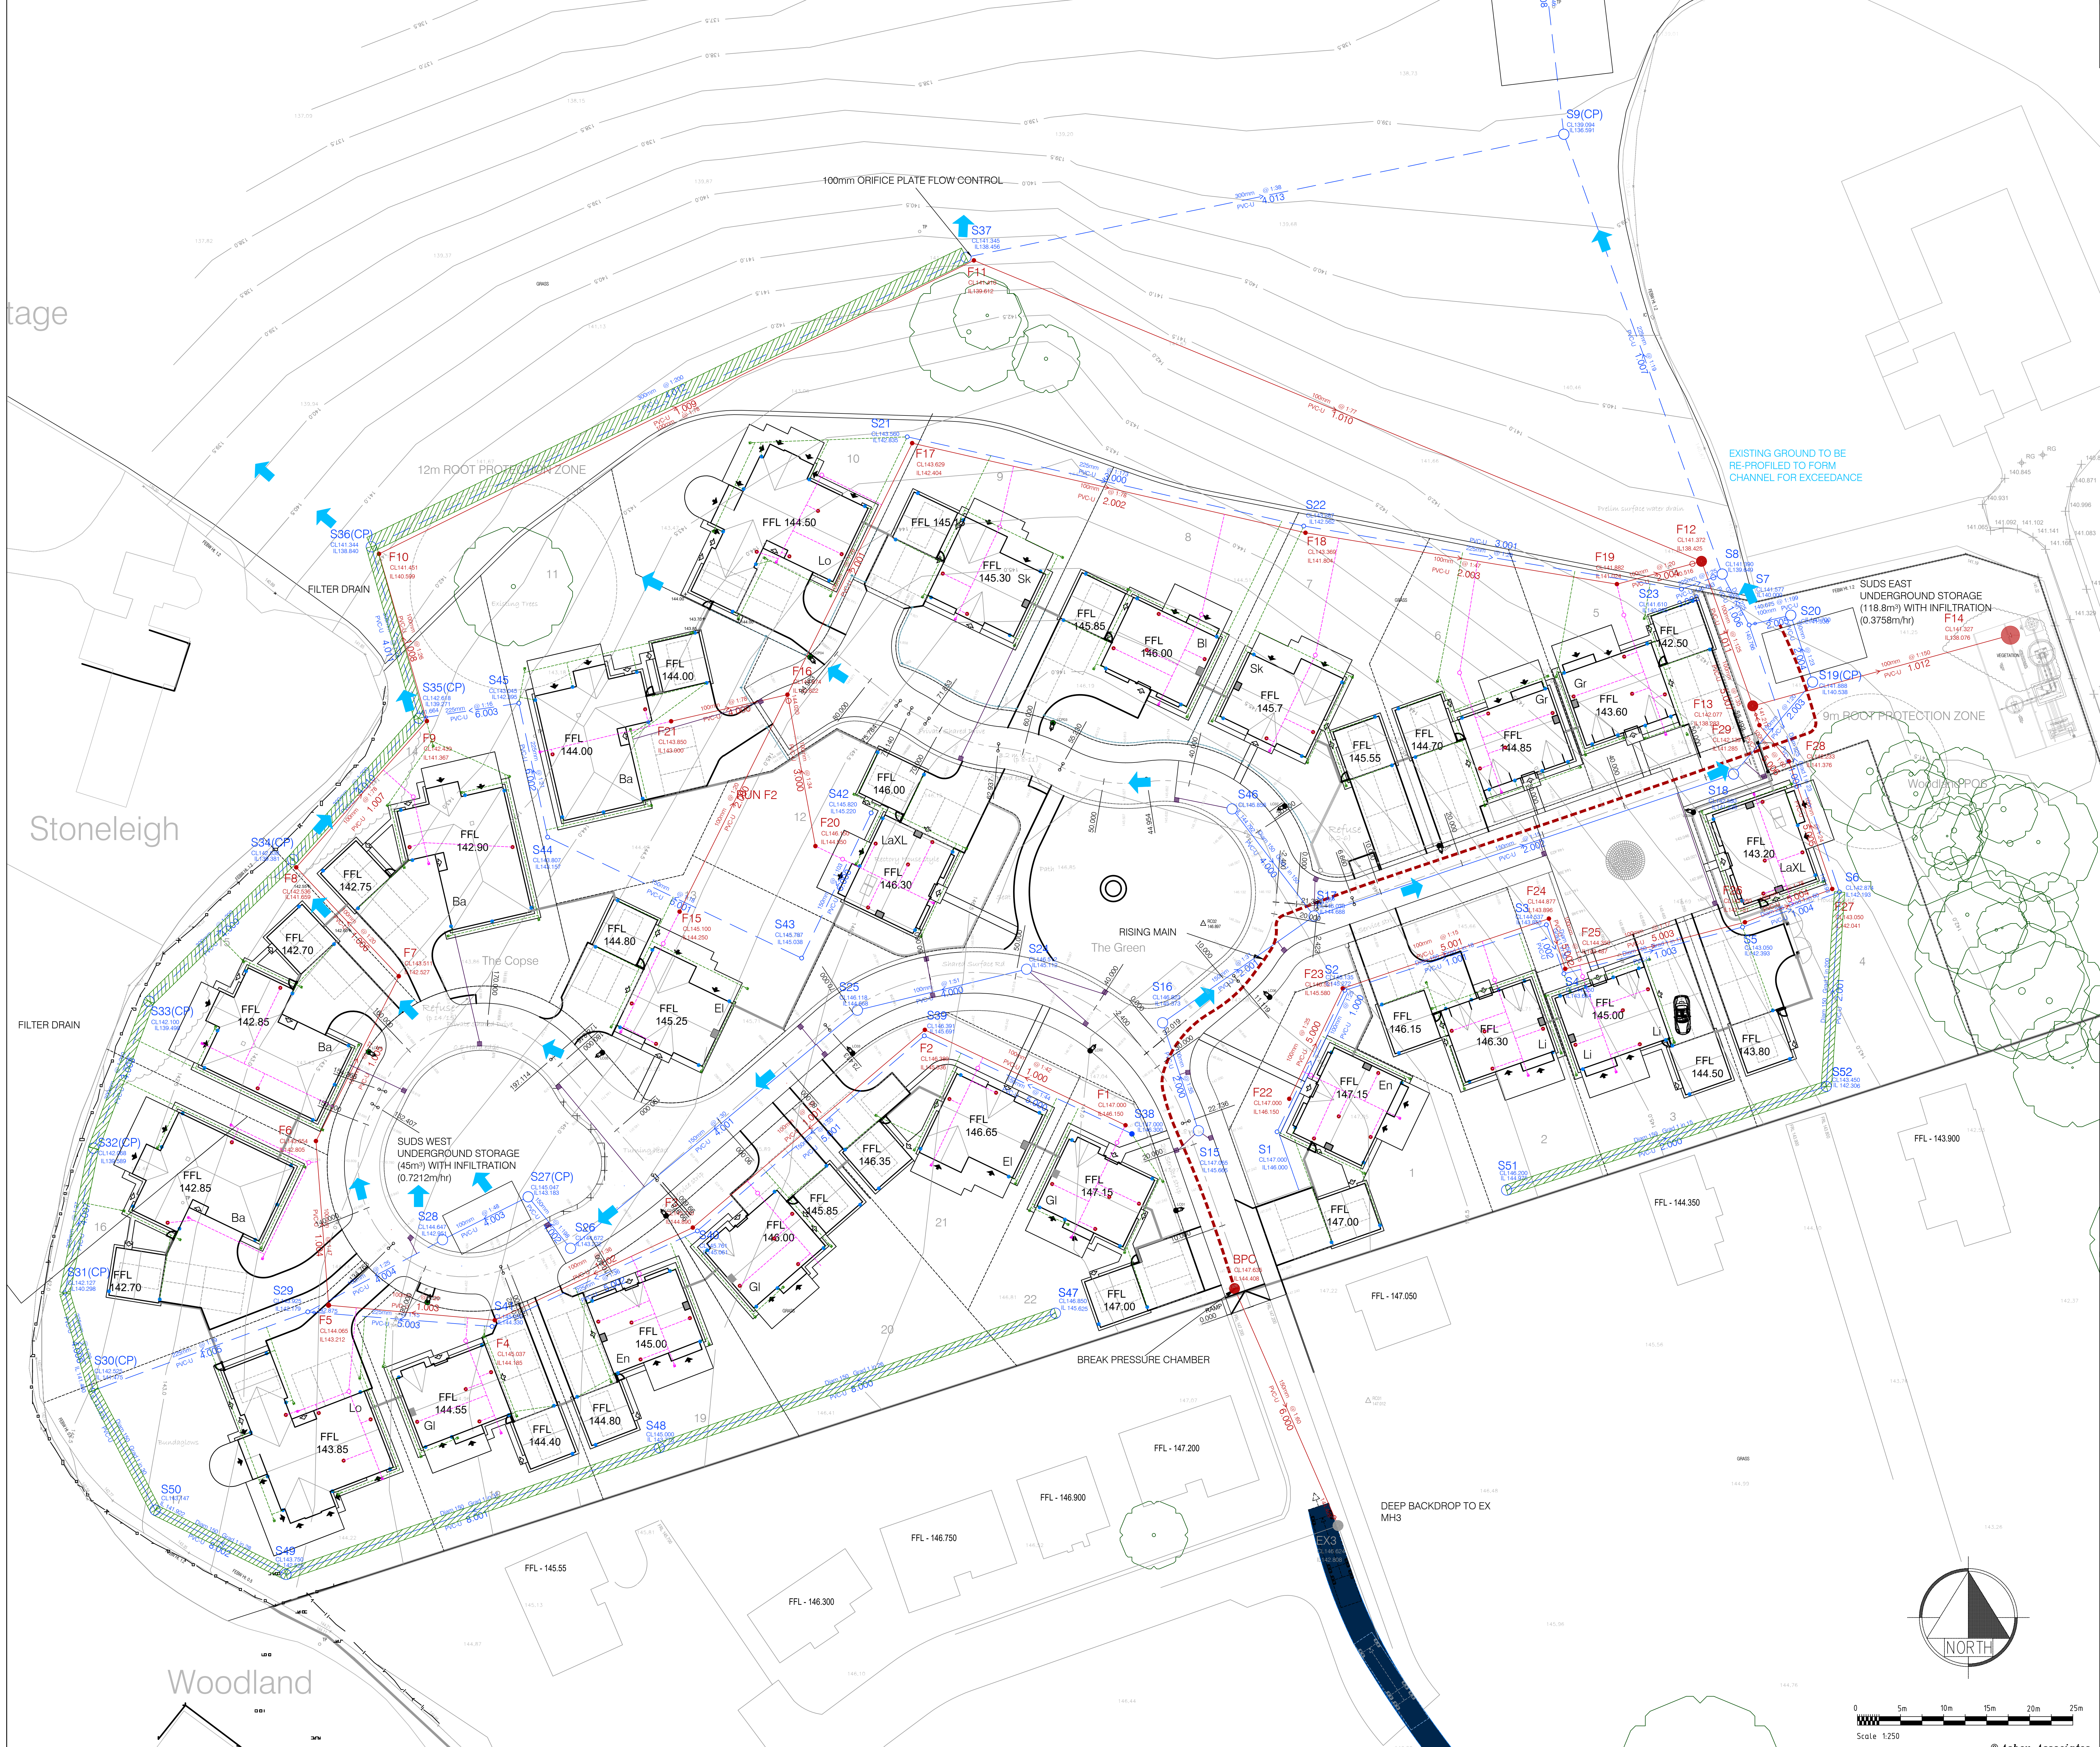

NOTES:

- DO NOT SCALE FROM THIS DRAWING.
- ALL DIMENSIONS ARE IN METRES UNLESS OTHERWISE STATED.

KEY: PROPOSED DRAINAGE

ADOPTABLE HIGHWAY DRAIN

PRIVATE SURFACE WATER DRAIN

PRIVATE FOUL SEWER

MANHOLE

MANHOLE WITH BACKDROP

CATCHPIT

HEADWALL

GULLY

CHANNEL DRAIN

SURFACE WATER INSPECTION CHAMBER

FOUL INSPECTION CHAMBER

RODDING EYE

RISING MAIN

DRAINAGE EXCEEDANCE ROUTE

INFILTRATION TRENCH

KEY:

STREETLIGHT

PRIVATE STREETLIGHT

Rev. B

Rev. A

Rev.

Amendment

Status

Appd.

Date

Client

KCS AGRICULTURAL LTD

Project

NORTH PARK RHEDA, PHASE 2

Title

DRAINAGE LAYOUT 1/3

Drawn

ROM

Date

23.05.24

Checked

WAM

Date

23.05.24

Approved

WAM

Date

23.05.24

Scales

1:250 @ A0

Job No.

AA7281

Client Drawing No.

Drawing No.

AA7281/EW/04

Rev.

B

0 5m 10m 15m 20m 25m

Scale 1:250

© Asher Associates

asher ASSOCIATES

CIVIL ENGINEERS
STRUCTURAL ENGINEERS
PROJECT MANAGERS

30 George Street, Duxford, Cambs CB1 1EH
Tel: 01387 250644 www.asherassociates.co.uk