


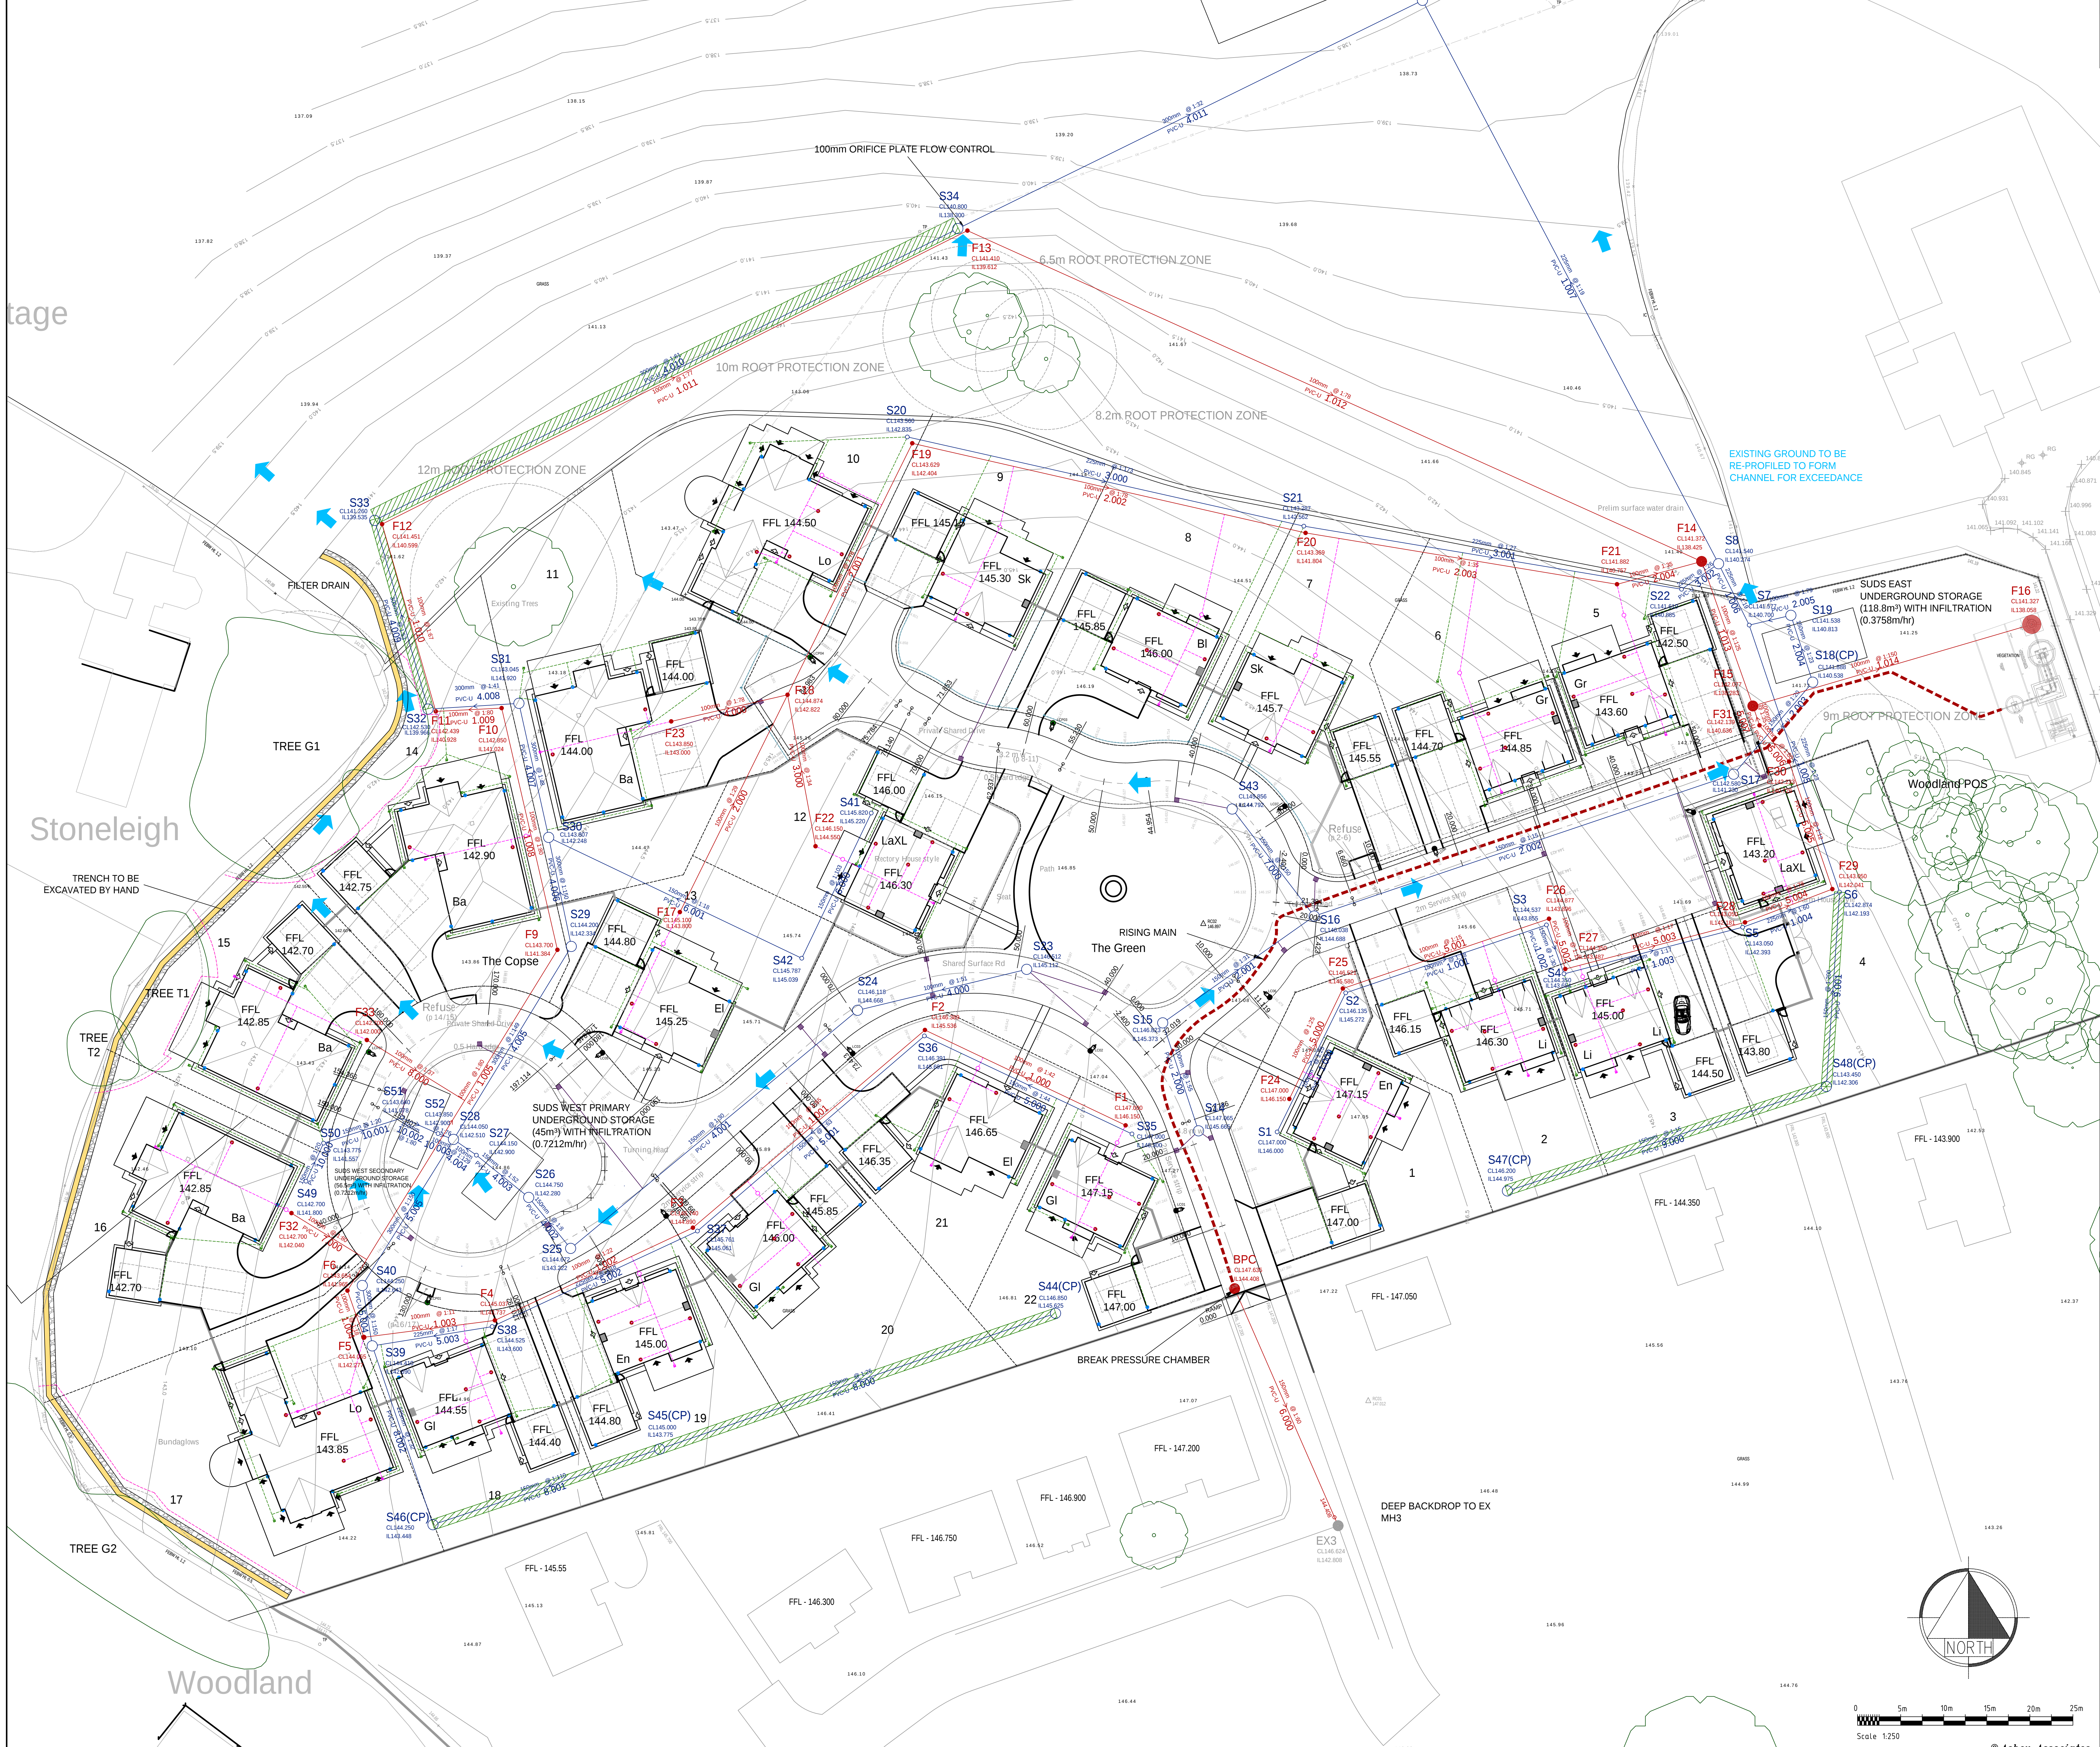

- NOTES.
1. DO NOT SCALE FROM THIS DRAWING.
 2. ALL DIMENSIONS ARE IN METRES UNLESS OTHERWISE STATED.

KEY: PROPOSED DRAINAGE

- ADOPTABLE HIGHWAY DRAIN
- PRIVATE SURFACE WATER DRAIN
- PRIVATE FOUL SEWER
- MANHOLE
- MANHOLE WITH BACKDROP
- CATCHPIT
- HEADWALL
- GULLY
- CHANNEL DRAIN
- SURFACE WATER INSPECTION CHAMBER
- FOUL INSPECTION CHAMBER
- RODDING EYE
- RIISING MAIN
- DRAINAGE EXCEEDANCE ROUTE
- INFILTRATION TRENCH
- KESTED HEDGE
- ROOT PROTECTION AREA
- EXISTING TREE CROWN SPREAD
- TREE PROTECTION FENCING

- KEY:
- STREETLIGHT
 - PRIVATE STREETLIGHT

Rev.	Amendment	By	Checked	Approved	Date
G	TREE CANOPIES AND ROOT PROTECTION ZONES AMENDED.	ROM	WAM	WAM	11/04/24
F	UPDATED AS PER A7281/EW/03H	ROM	WAM	WAM	11/04/24
E	UPDATED AS PER A7281/EW/03G	ROM	WAM	WAM	11/04/24
D	UPDATED AS PER A7281/EW/02F	ROM	WAM	WAM	11/04/24
C	UPDATED AS PER A7281/EW/02E	ROM	WAM	WAM	11/04/24
B	INFILTRATION TRENCH ADDED TO KEY. LIGHTING COLUMNS SHOWN.	RJ	WAM	WAM	11/04/24
A	UPDATED AS PER A7281/EW/03C	ROM	WAM	WAM	11/04/24

PLANNING APPLICATION

Status Appd. Date

KCS AGRICULTURAL LTD

Project NORTH PARK RHEDA, PHASE 2

Title DRAINAGE LAYOUT 1/3

Drawn ROM Date 23.05.24 Checked WAM Date 23.05.24 Approved WAM Date 23.05.24

asher ASSOCIATES
CIVIL ENGINEERS
STRUCTURAL ENGINEERS
PROJECT MANAGERS
30 George Street, Dymally, D61 1EH
T: 01287 256644 www.asherassociates.co.uk

Scale 1:250

Job No. AA7281
Client Drawing No.
Drawing No. AA7281/EW/04

Rev. G