

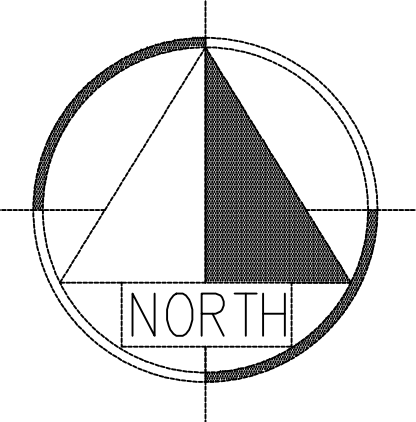


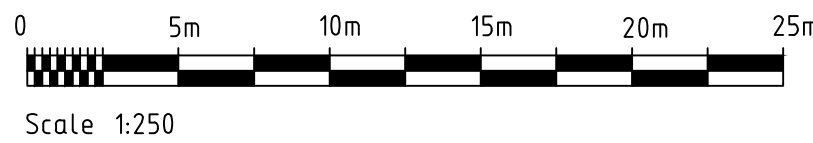

- NOTES.
1. DO NOT SCALE FROM THIS DRAWING.
 2. ALL DIMENSIONS ARE IN METRES UNLESS OTHERWISE STATED.

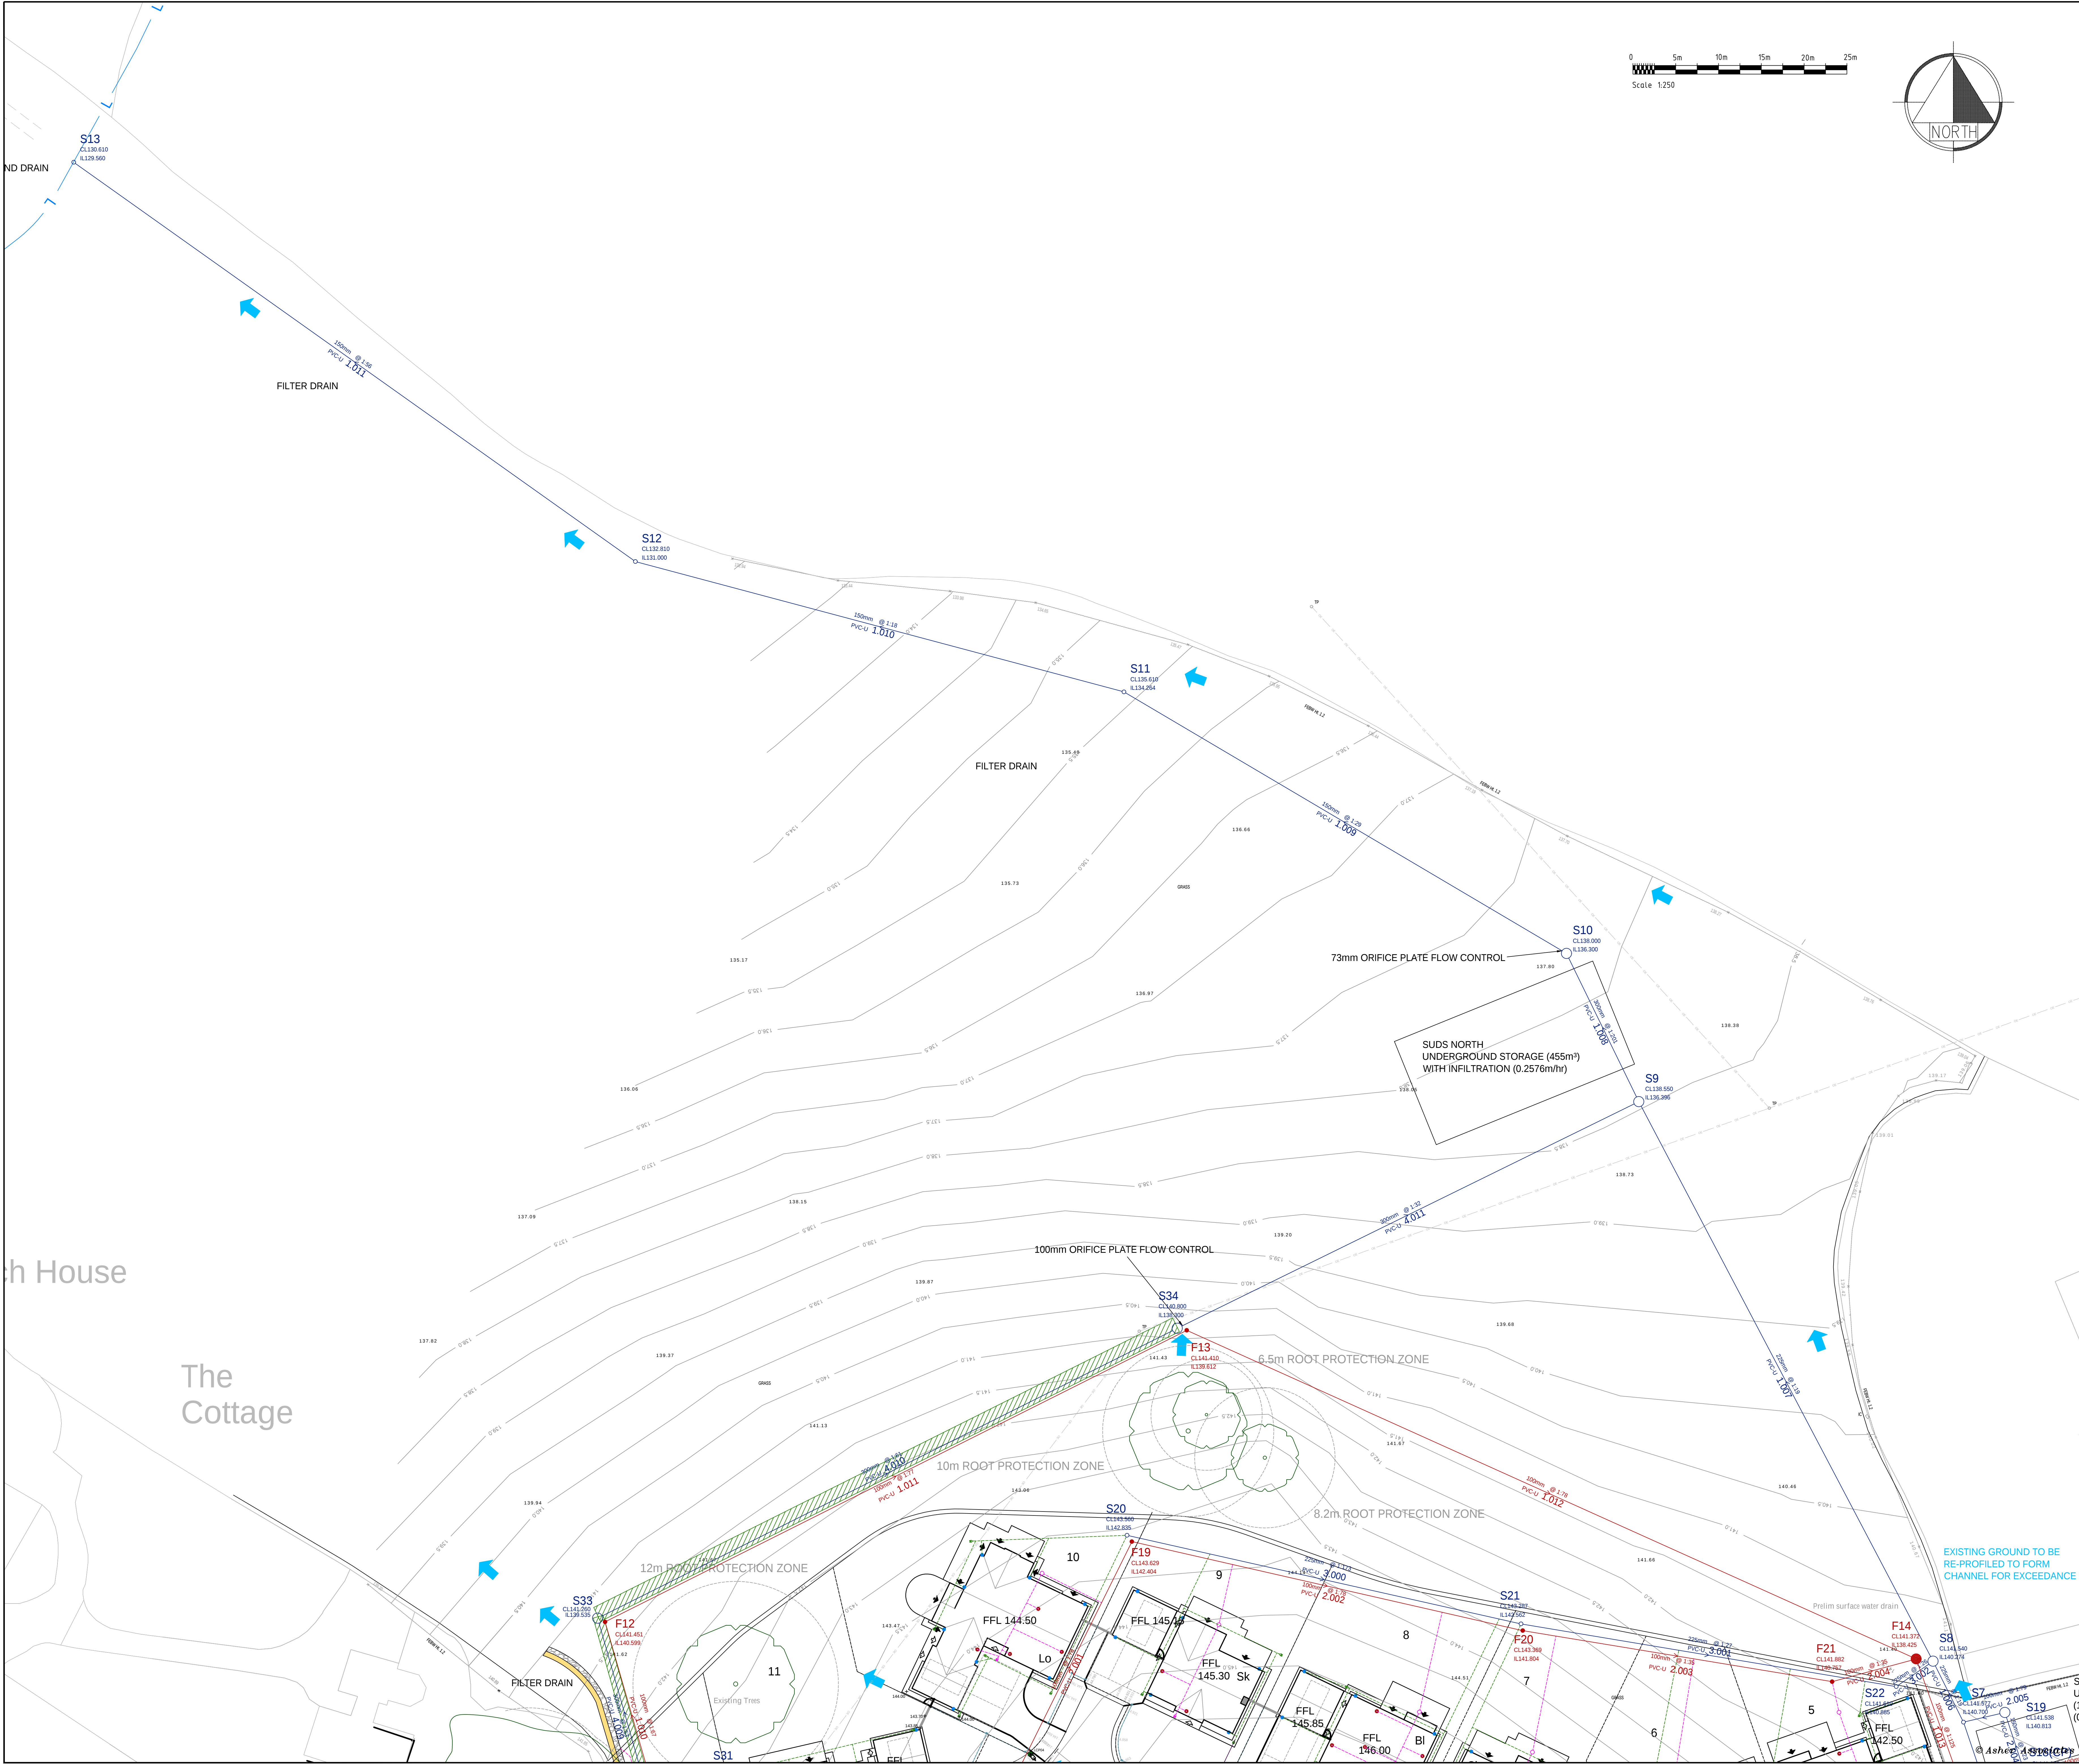

KEY: PROPOSED DRAINAGE

- ADOPTABLE HIGHWAY DRAIN
- PRIVATE SURFACE WATER DRAIN
- PRIVATE FOUL SEWER
- MANHOLE
- MANHOLE WITH BACKDROP
- CATCHPIT
- HEADWALL
- GULLY
- CHANNEL DRAIN
- SURFACE WATER INSPECTION CHAMBER
- FOUL INSPECTION CHAMBER
- RODDING EYE
- RISING MAIN
- DRAINAGE EXCEEDANCE ROUTE
- INFILTRATION TRENCH
- KESTED HEDGE
- ROOT PROTECTION AREA
- EXISTING TREE CROWN SPREAD
- TREE PROTECTION FENCING

- KEY:
- STREETLIGHT
 - PRIVATE STREETLIGHT

G	TREE CANOPIES AND ROOT PROTECTION ZONES AMENDED.	ROM	WAM	WAM	11/04/24
E	UPDATED AS PER A7281/EW/03H	ROM	WAM	WAM	11/04/24
D	UPDATED AS PER A7281/EW/03G	ROM	WAM	WAM	11/04/24
U	UPDATED AS PER A7281/EW/02F	ROM	WAM	WAM	11/04/24
C	UPDATED AS PER A7281/EW/03E	ROM	WAM	WAM	11/04/24
B	INFILTRATION TRENCH ADDED TO KEY. LIGHTING COLUMNS SHOWN.	RJ	WAM	WAM	11/04/24
A	UPDATED AS PER A7281/EW/03C	ROM	WAM	WAM	11/04/24

Rev.	Amendment	By	Checked	Approved	Date
------	-----------	----	---------	----------	------

PLANNING APPLICATION

Status	Appd.	Date
--------	-------	------

KCS AGRICULTURAL LTD

NORTH PARK RHEDA,
PHASE 2

DRAINAGE LAYOUT 2/3

Drawn	Date	Checked	Date	Approved	Date
ROM	23.05.24	WAM	23.05.24	WAM	23.05.24

asher ASSOCIATES
CIVIL ENGINEERS
STRUCTURAL ENGINEERS
PROJECT MANAGERS
32 George Street, Dummies D61 1EH
01287 250644 - www.asherassociates.co.uk

Scales: 1:250 @ A0

Job No.: AA7281

Client Drawing No.: AA7281

Drawing No.: AA7281/EW/05

Rev.: G