


NOTES

- THIS DRAWING IS COPYRIGHT AND MUST NOT BE REPRODUCED WITHOUT THE WRITTEN PERMISSION OF PETTIT SINGLETON ASSOCIATES
- THIS DRAWING SHALL BE READ IN CONJUNCTION WITH ALL LATEST ARCHITECTS' DRAWINGS, SPECIFICATIONS, AND ANY DISCREPANCY BETWEEN THE DRAWINGS AND THE SPECIFICATIONS SHALL BE BROUGHT TO THE ATTENTION OF THE ENGINEER, PETTIT SINGLETON ASSOCIATES
- DO NOT SCALE THE POSITION OF ANY ITEM OF EQUIPMENT OR OUTLET ON THE DRAWING
- THERE SHALL BE NO CHANGES TO THE PROPOSALS WITHOUT THE AGREEMENT OF THE ENGINEER
- ALLOW A DOUBLE PIPE SET WHEREVER PIPES PASS THROUGH WALLS, FLOORS AND CEILINGS TO ALLOW FOR POSSIBLE STRUCTURAL OBSTRUCTIONS
- DRAIN COCKS TO BE INSTALLED AT LOW POINTS AND AIR VENTS AT ALL HIGH POINTS
- ALL WORKS TO BE FULLY IN ACCORDANCE WITH LOCAL AND MODEL BYELAWS AND GAS SAFETY REQUIREMENTS
- ALL STEEL WORK FOR THE SUPPORT OF PLANT AND PIPEWORK SHALL BE PROVIDED BY THE MECHANICAL CONTRACTOR
- ALL PIPEWORK PASSING THROUGH WALLS AND FLOORS SHALL BE SLEEVED
- ALL NEW PIPEWORK TO BE PAINTED PRIOR TO INSTALLATION
- CONTRACTOR TO INCLUDE FOR CO-ORDINATING HIS WORK WITH ALL OTHER TRADES
- ALL PIPEWORK PASSING THROUGH FIRE BARRIERS AND BUILDS SHALL PASS THROUGH FIRE SLEEVES
- CONTRACTOR TO INCLUDE IN HIS TENDER FOR ALL DRAINING DOWN AND REFILLING OF THE SYSTEM IN ORDER TO COMPLETE THE WORKS
- CONTRACTOR SHALL ALLOW FOR ALL ADDITIONAL FITTINGS AND BENDS NECESSARY TO AVOID EXISTING PIPEWORK ETC
- CONTRACTOR TO INCLUDE FOR ALL EXPOSED PIPEWORK TO BE INSULATED AND SLOPED IN ALL BEING TO BE PAINTED OUT TO MATCH SURROUNDINGS

HEATING LEGEND

- PIPE JOINT
- PIPE DROP
- PIPE RISE
- RADIATOR
- PIPEWORK IN FLOOR VOID
- PIPEWORK AT LOW LEVEL
- PIPEWORK AT HIGH LEVEL
- PIPEWORK IN CEILING VOID
- ELECTRIC UNDERFLOOR HEATING

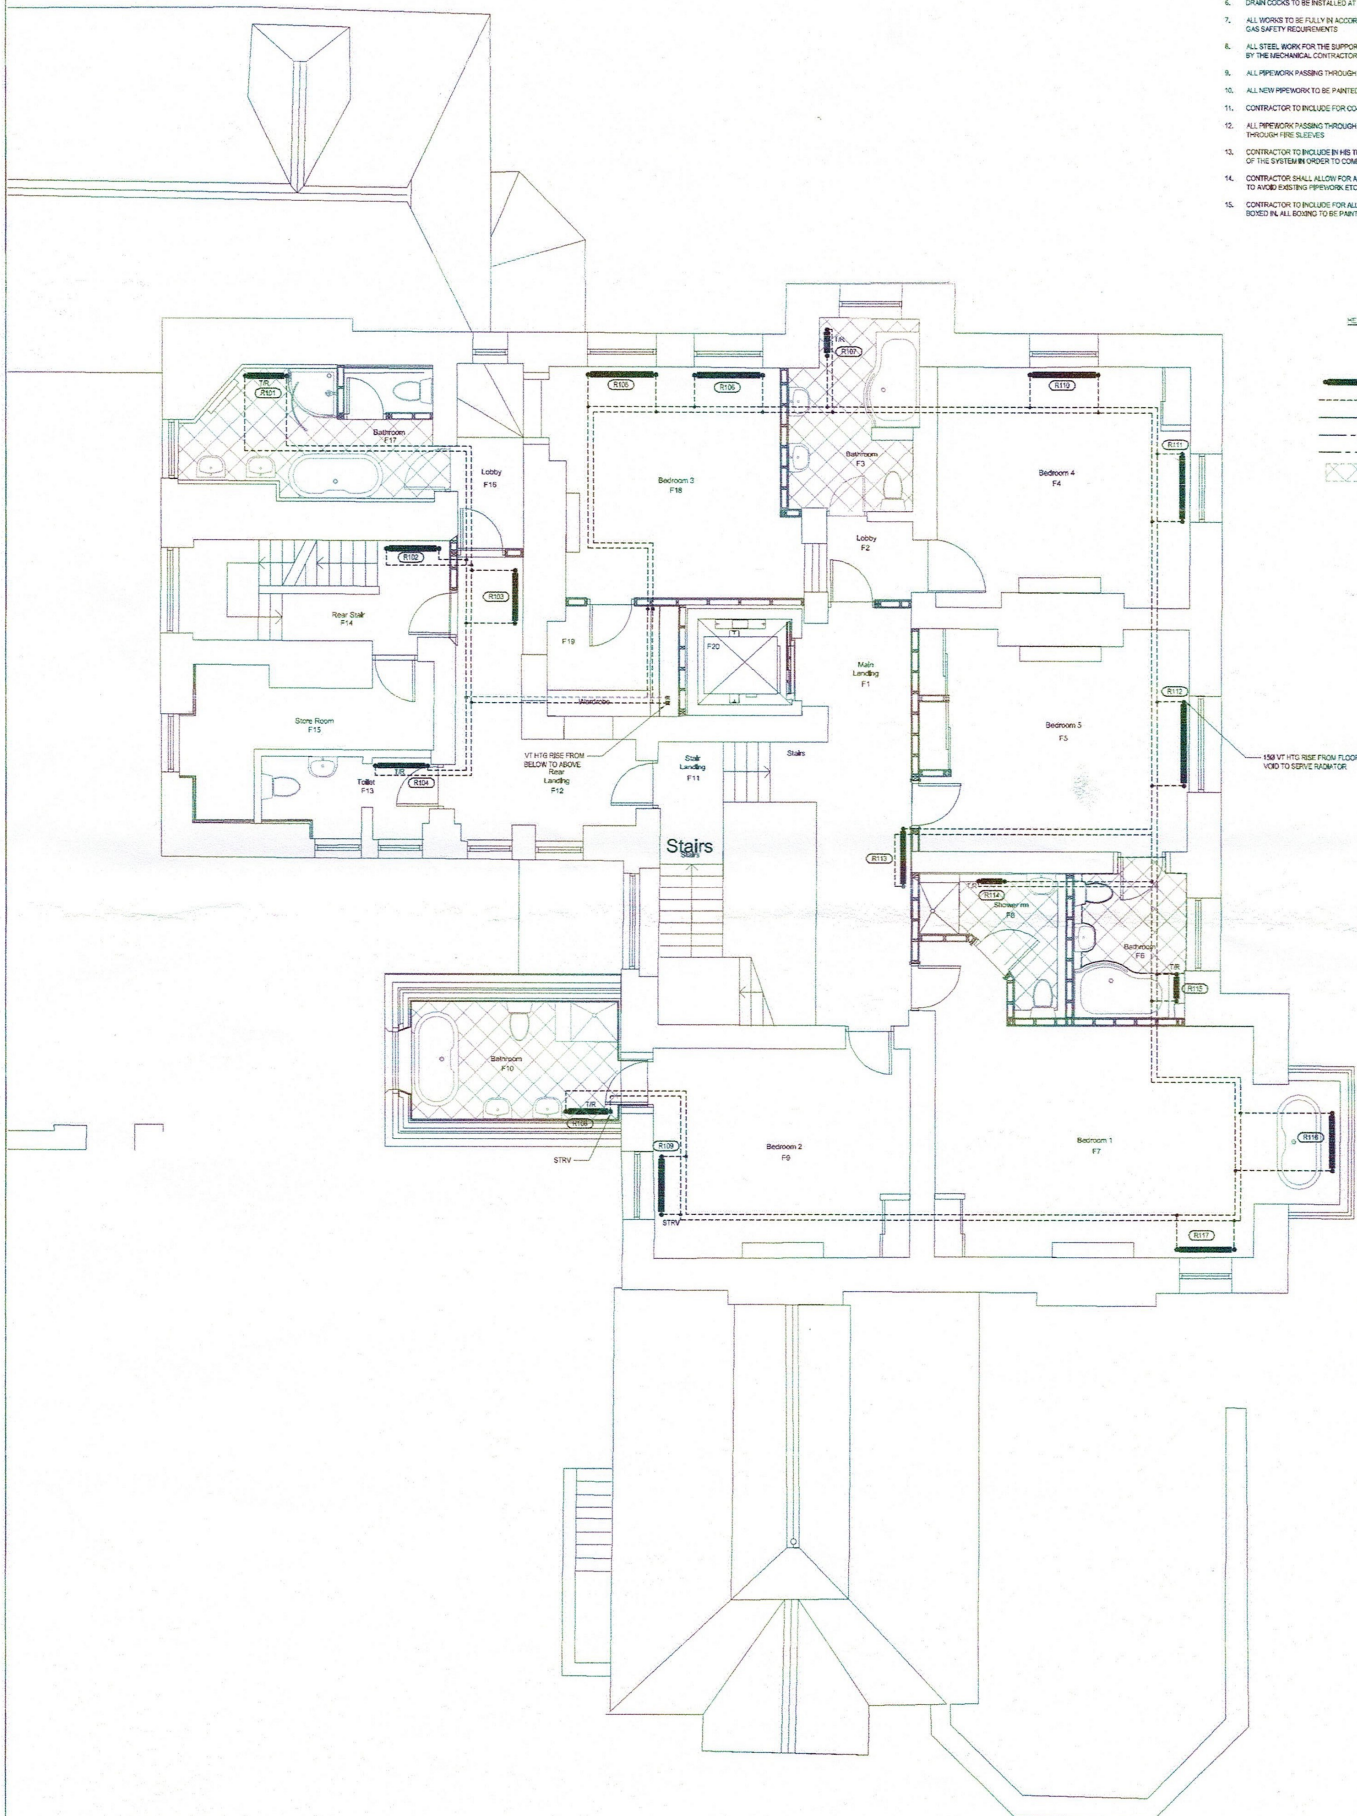

Rev.	Date	Details	Iss.	General Notes
01	25/07/18	PRELIMINARY ISSUE	001	
02			002	
03			003	
04			004	
100			100	

This drawing is copyright and may not be altered, reproduced or used other than for the purposes for which it is intended without the written consent of Pettit Singleton.

The purpose of this drawing when issued as a tender drawing is to enable tenders to be prepared accurately to the design and to avoid competitive tenders for the works.

This drawing shall be read in conjunction with the tender specifications.

Do not scale this drawing if it must, see below scale.

10-11 Dunningwell House, Dunningwell, Fife, Scotland, FK2 2PP
T: 01792 722211
E: info@dunningwell.co.uk

10-11 Dunningwell House, Dunningwell, Fife, Scotland, FK2 2PP
T: 01792 722211
E: info@dunningwell.co.uk

PSA
PETTIT SINGLETON ASSOCIATES

DATE: JUL 18
SCALE: 1:50 @ A1

☒ PRELIMINARY
☐ APPROVAL COMMENT
☐ TENDER
☐ CONSTRUCTION

CLIENT: DUNNINGWELL LTD
PROJECT: DUNNINGWELL HOUSE
DRAWING: HEATING SERVICES LAYOUT
FLOOR: FIRST FLOOR