


DO NOT SCALE – IF IN DOUBT ASK
USE FIGURED DIMENSIONS ONLY

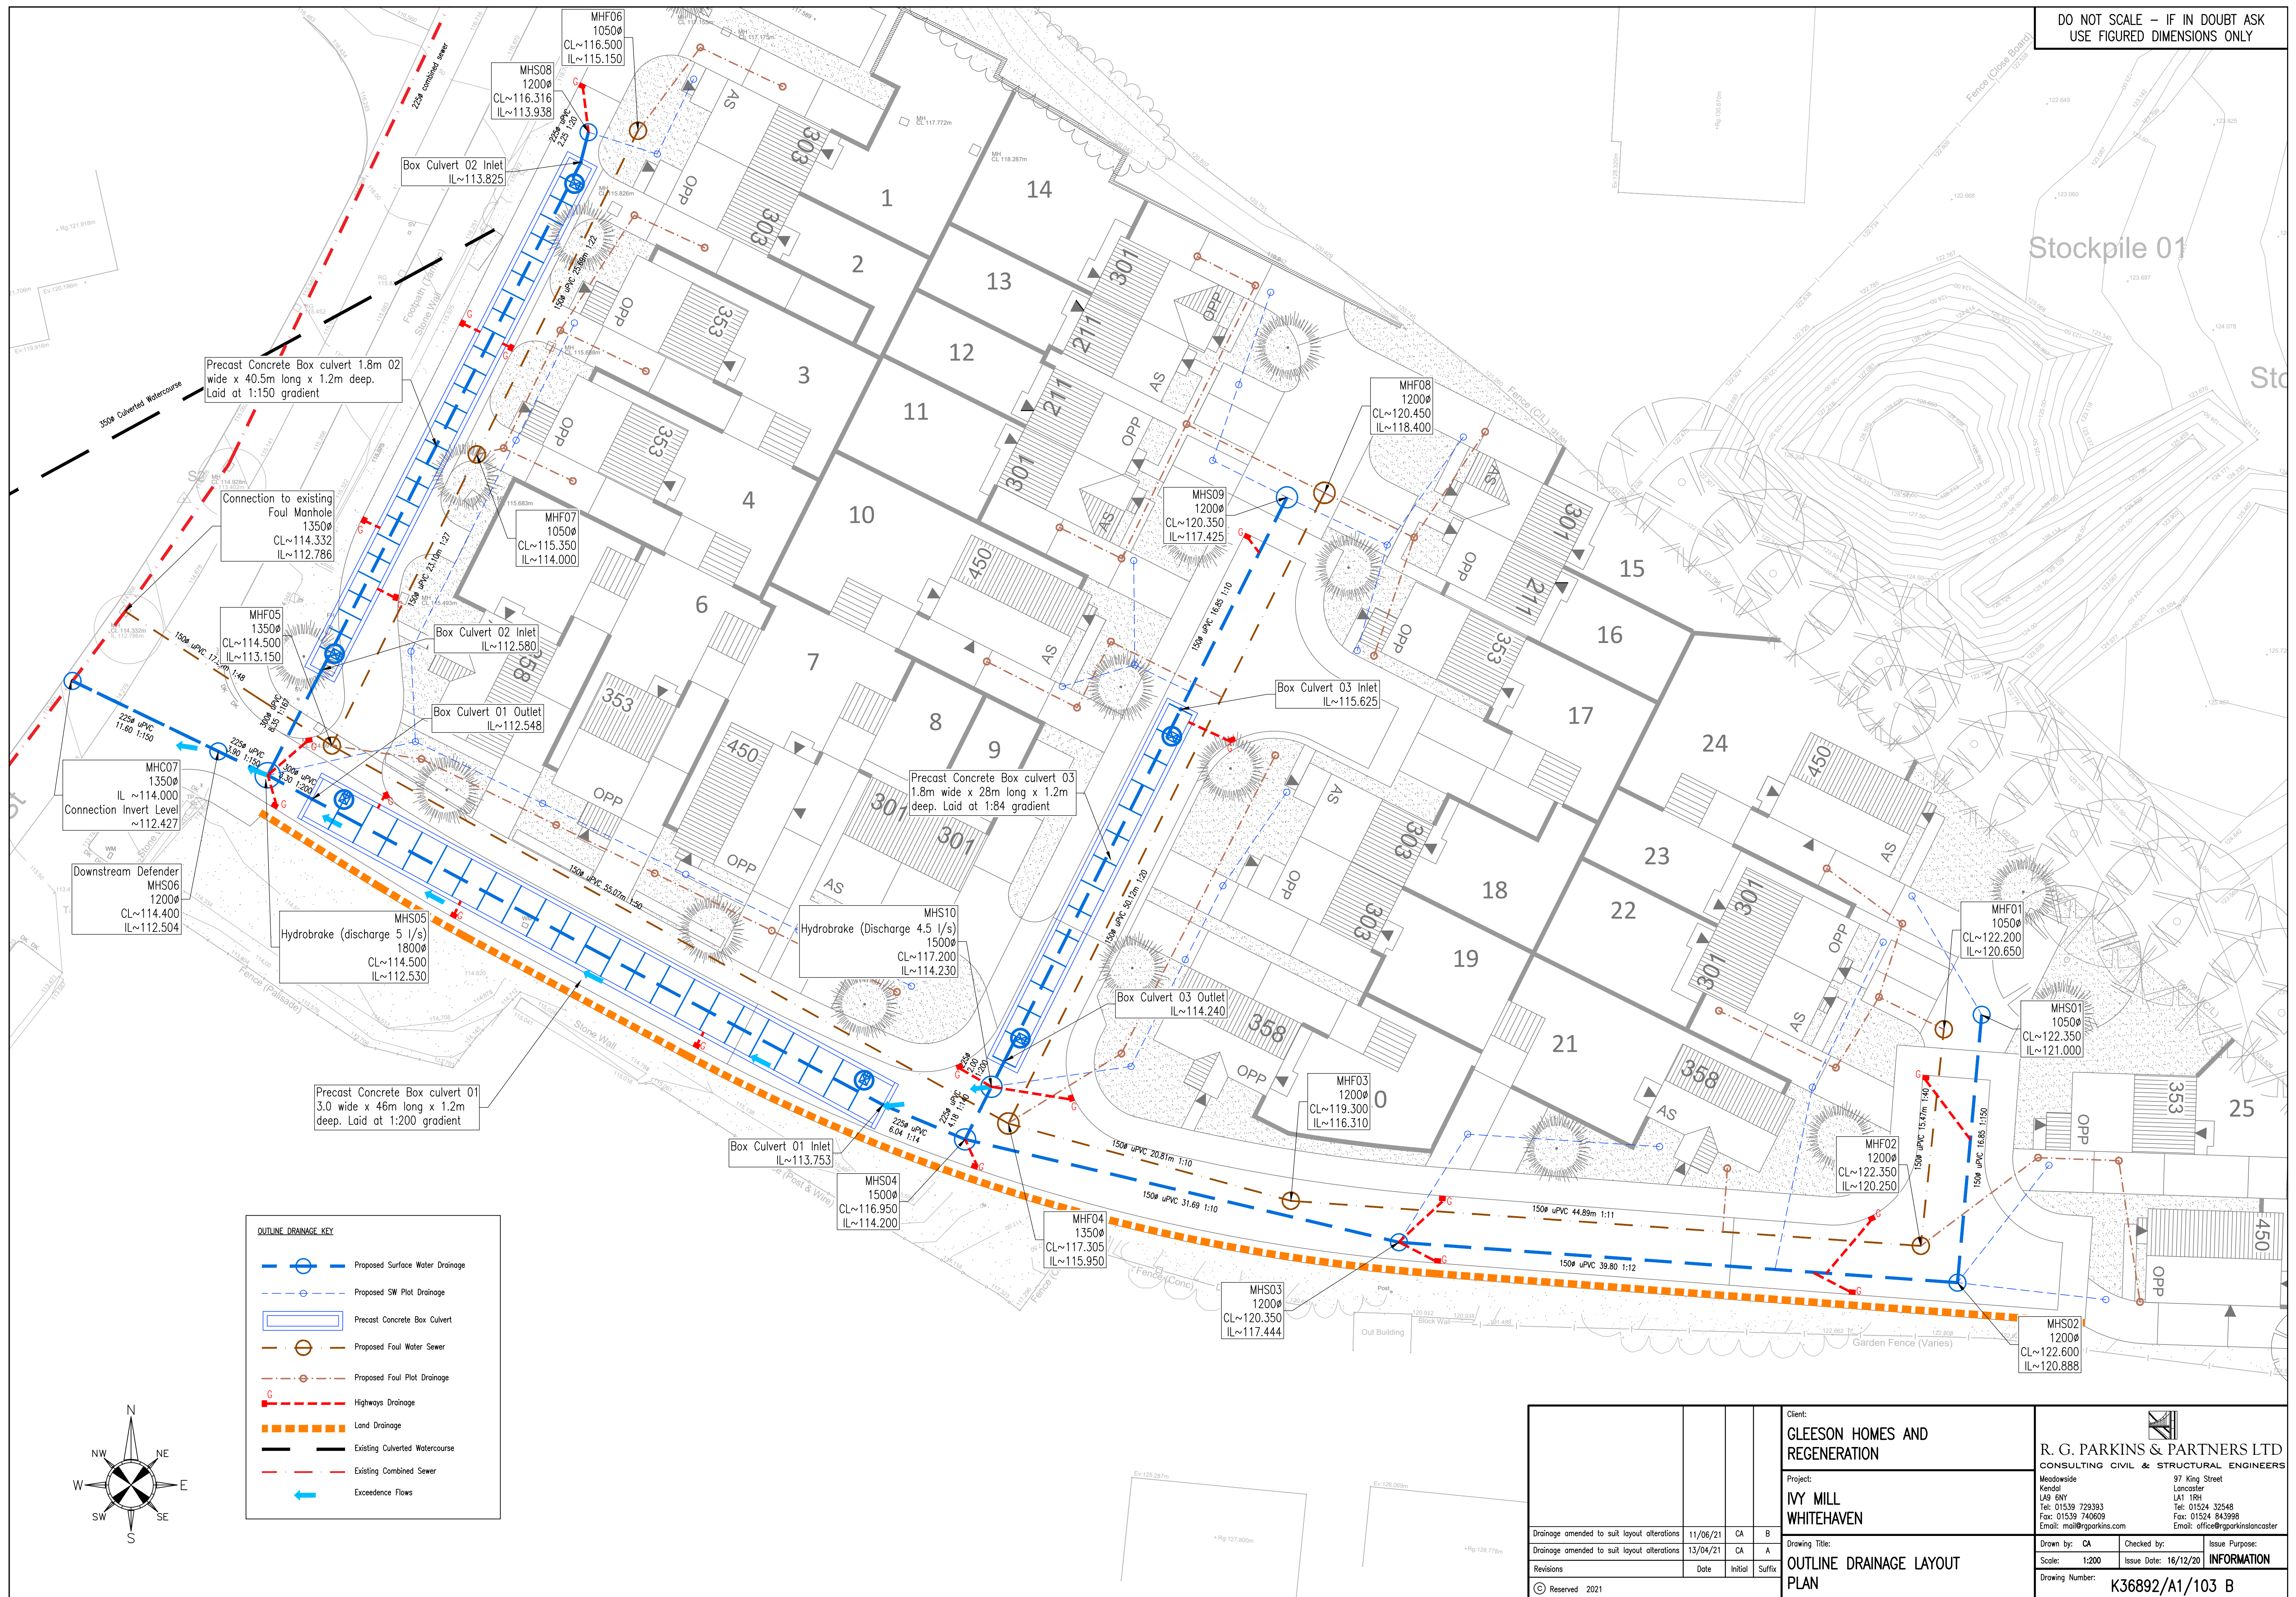

				Client: GLEESON HOMES AND REGENERATION		 R. G. PARKINS & PARTNERS LTD CONSULTING CIVIL & STRUCTURAL ENGINEERS			
				Project: IVY MILL WHITEHAVEN		97 King Street Lancaster LA1 1PR Tel: 01524 32548 Fax: 01524 843998 Email: office@rgparkins.co.uk			
Drainage amended to suit layout alterations		11/06/21	CA	B	Drawing Title: OUTLINE DRAINAGE LAYOUT PLAN	Drawn by: CA		Checked by:	Issue Purpose:
Drainage amended to suit layout alterations		13/04/21	CA	A		Scale: 1:200		Issue Date: 16/12/20	INFORMATION
Revisions		Date	Initial	Suffix		Drawing Number:		K36892/A1/103 B	
© Reserved 2021									