


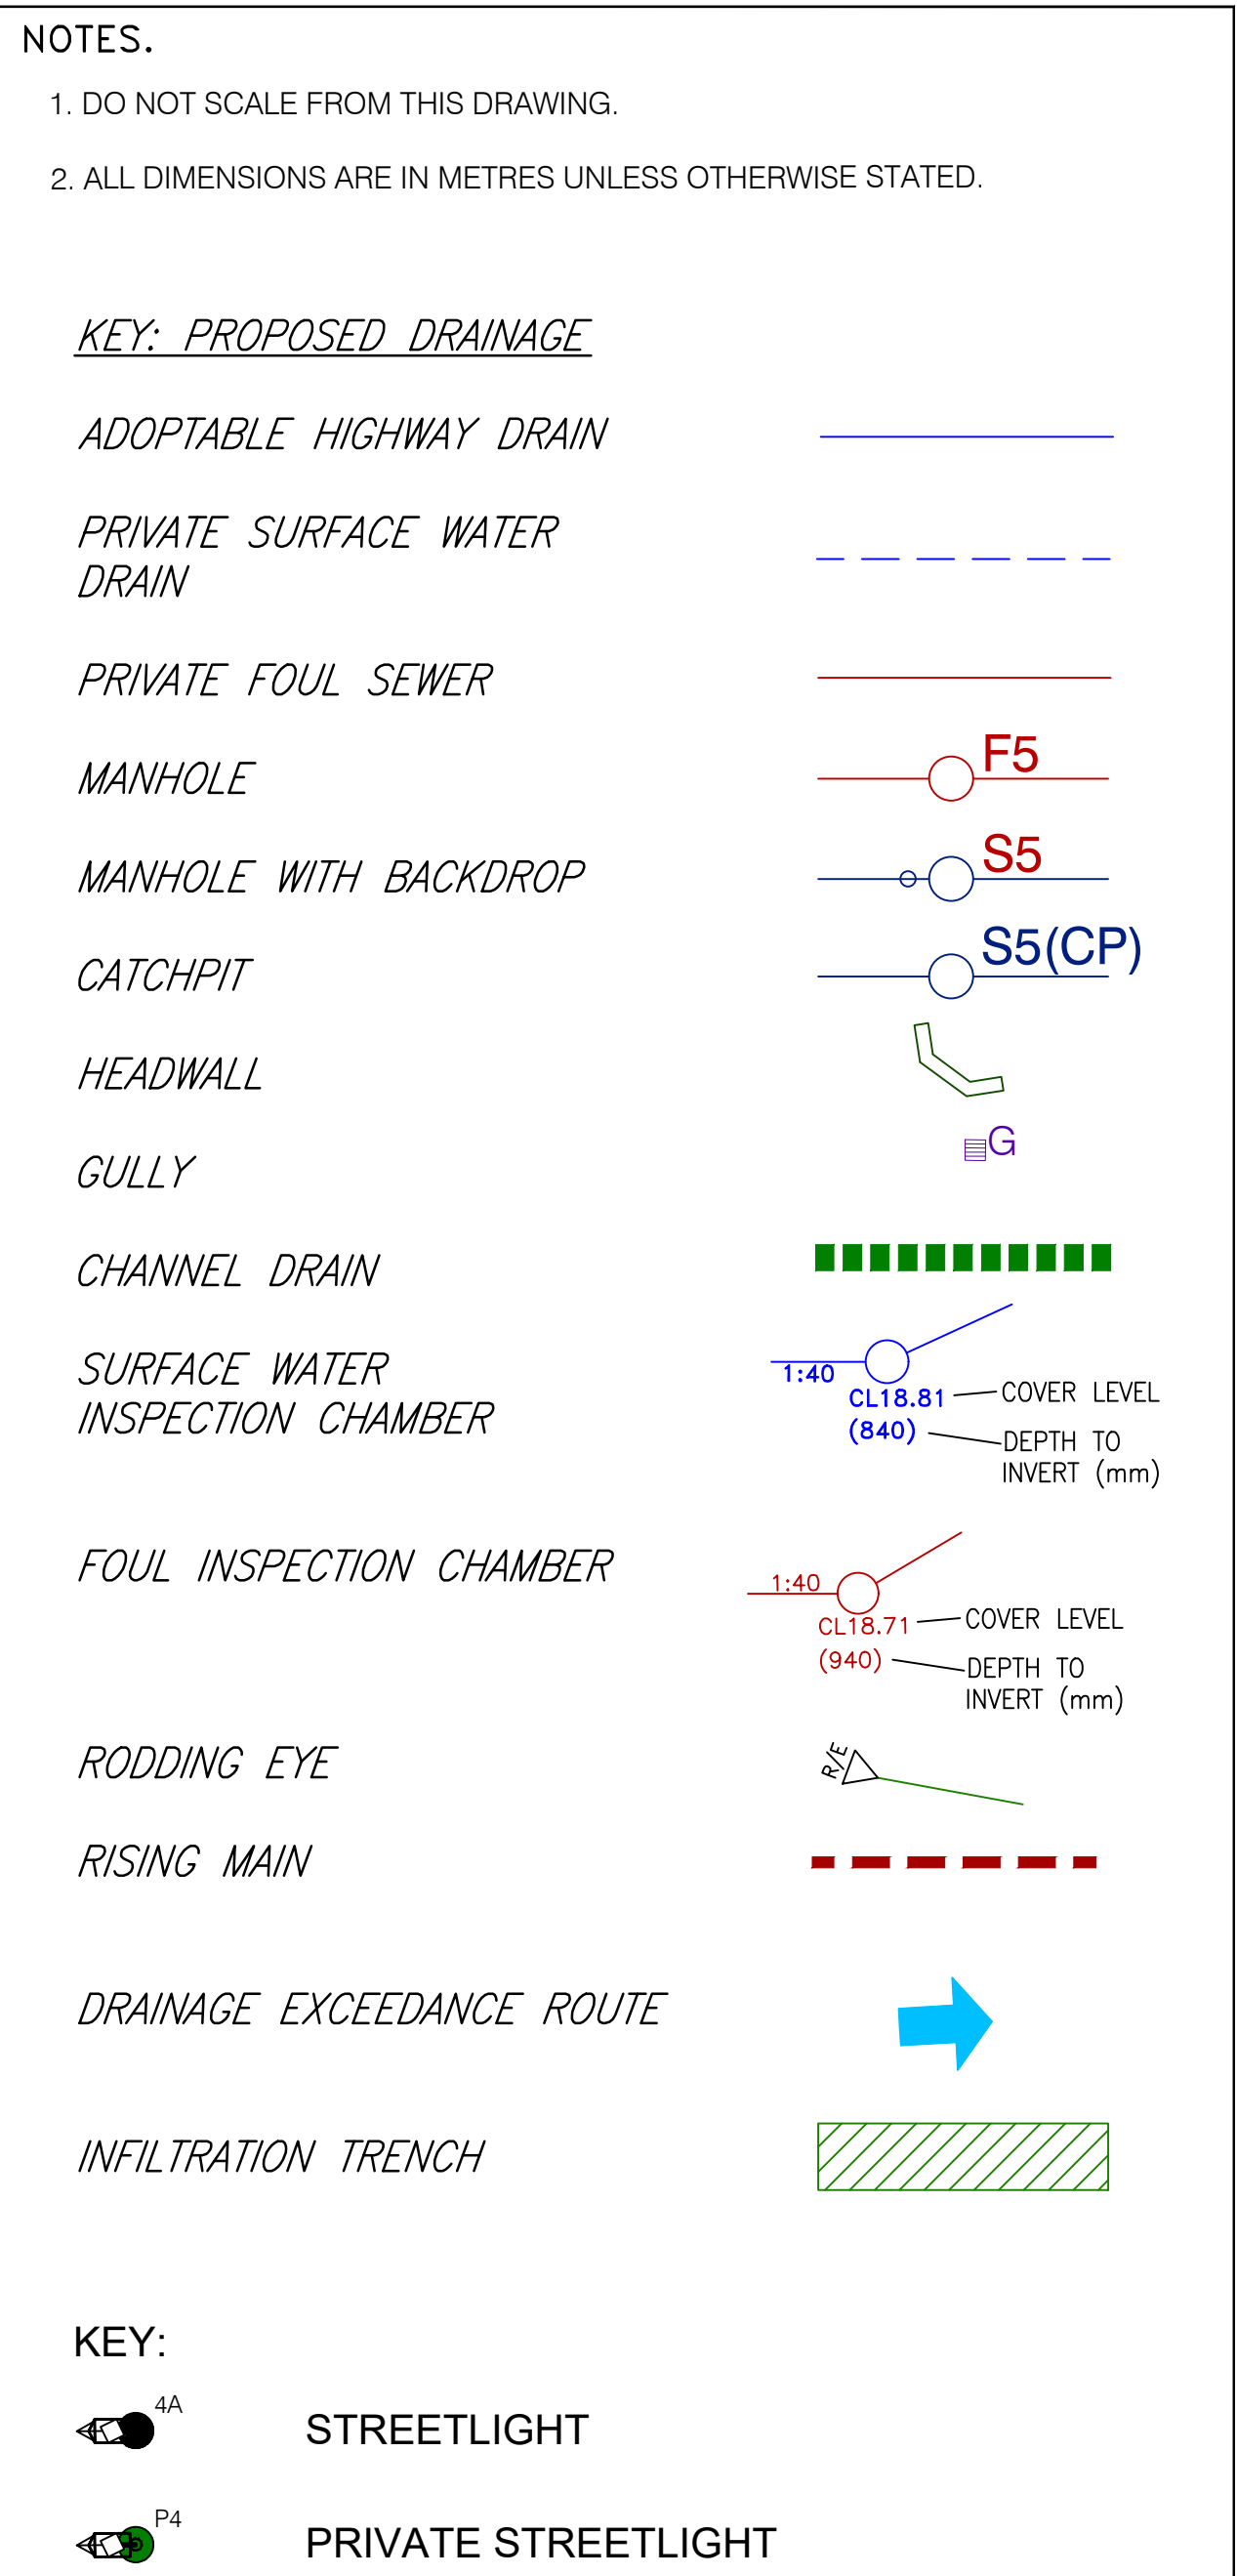

C	INFILTRATION TRENCH ADDED TO KEY. LIGHTING COLUMNS SHOWN.	RJ	WAM	WAM	23.05.24	
B	MANHOLES S46 TO S50 ADDED; COVER LEVELS UPDATED; DRAINAGE EXCEEDANCE ROUTE ADDED; MANHOLES S2 TO S8 ALTERED, SUDS NORTH & WEST ALTERED.	ROM	WAM	WAM	23.05.24	
A	GULLIES ADDED	ROM	WAM	WAM	23.05.24	
Rev.	Amendment	By	Checked	Approved	Date	
PLANNING APPLICATION						
Status				Appd.	Date	
Client						
KCS AGRICULTURAL LTD						
Project						
NORTH PARK RHEDA, PHASE 2						
Title						
OVERALL DRAINAGE LAYOUT						
Drawn	Date	Checked	Date	Approved	Date	
ROM	23.05.24	WAM	23.05.24	WAM	23.05.24	
 asher ASSOCIATES CIVIL ENGINEERS STRUCTURAL ENGINEERS PROJECT MANAGERS 12 George Street, Dunfermline D01 1EH 01382 226044 - www.asherassociates.co.uk		Scales 1:500 @ A0				
		Job No. AA7281				
		Client Drawing No.				
		Drawing No. AA7281/EW/03				
		Rev.				